



SCHEMA ELECTRIQUE DE POSITIONNEMENT (ATELIER/DEPOU)
 APPARTEMENTSGEBOUW AGRAPINE RADIAN
 NINOOFSESTEENWEG, 884-886
 1700 DILBECK

Datum: 28 november 2012
 Schaal: 1/100

KELDERVERDIEPING

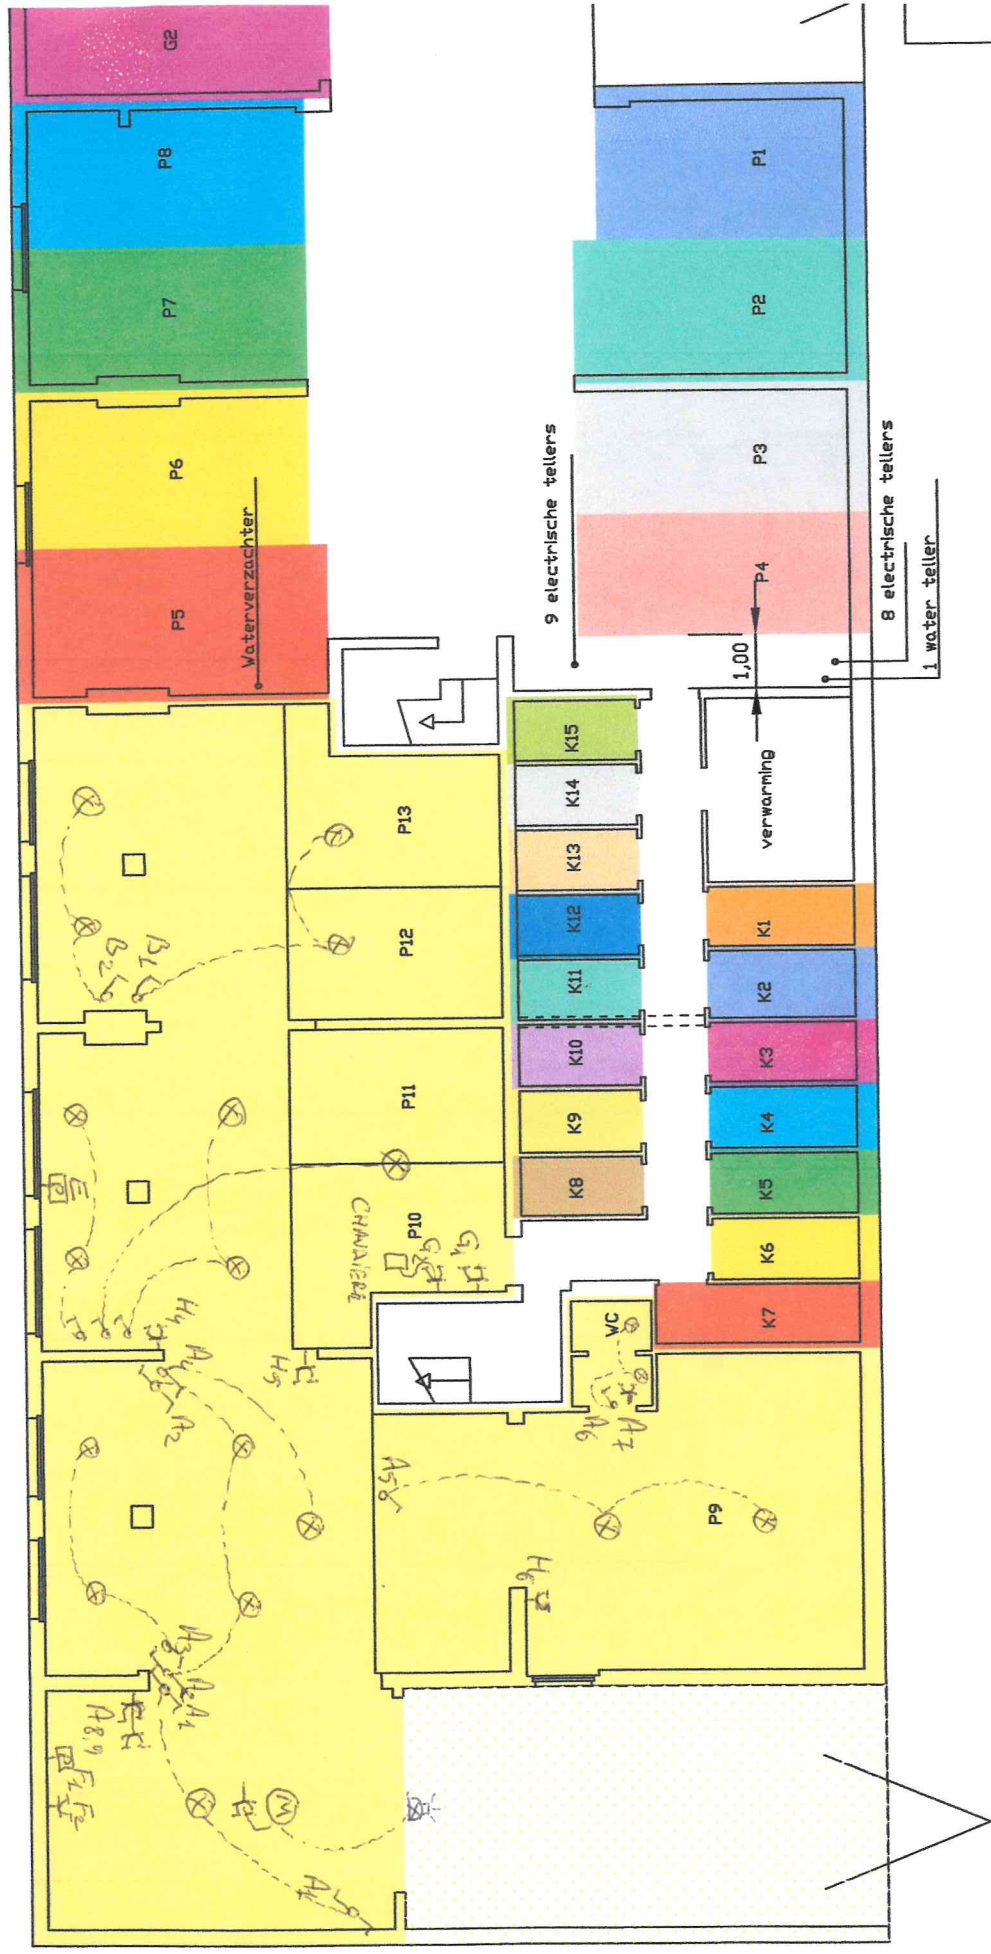

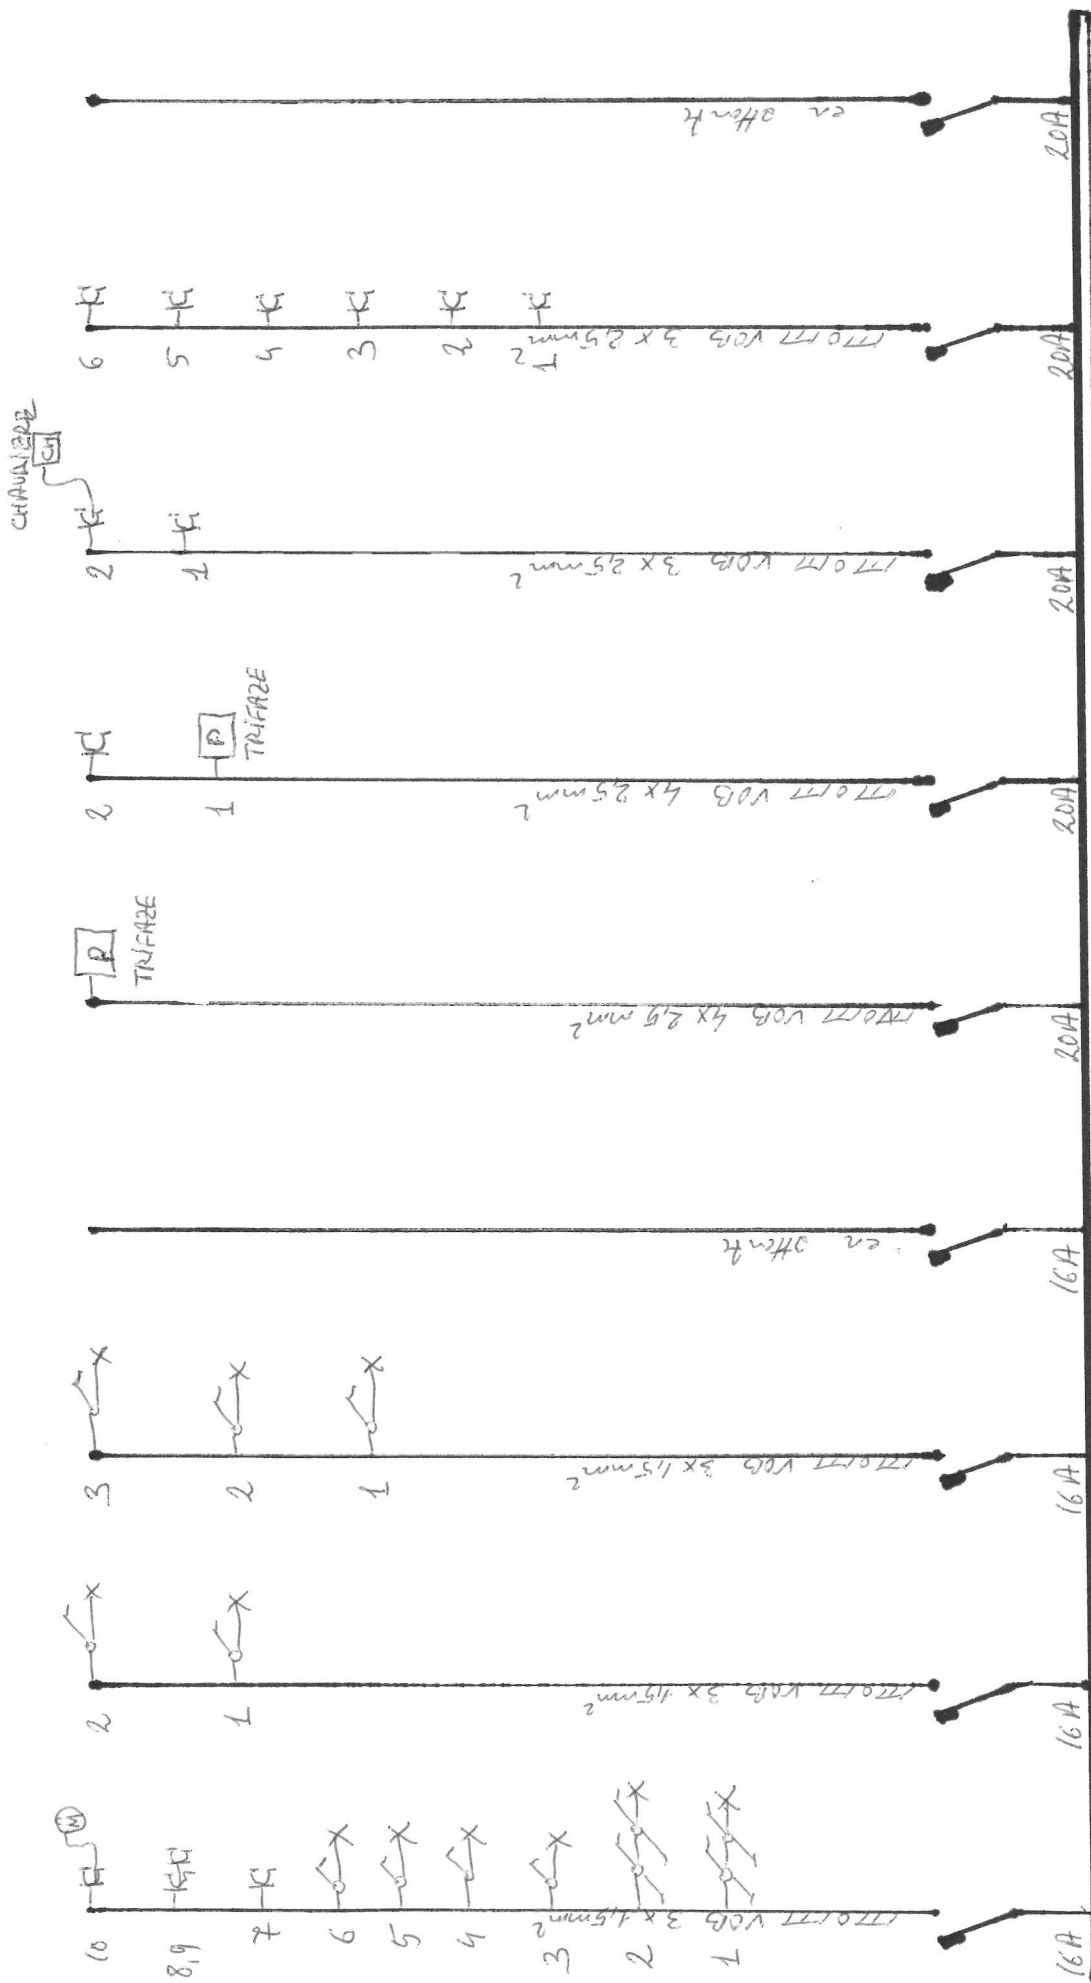

A J H I

SCHEMA UNIFILAIRE ATELIER (AEPD)
 NINOOFSESTEENWEG 884-886
 1700 DILBECK
 AGRARIË BARIAN

Handwritten signature

